



- General Notes :**
1. No part of this document may be re-produced or transmitted in any form or stored in any retrieval system without the written permission of the Consulting Engineer, David Kelly Partnership, as copyright holder except as agreed for use on the project for which the document was originally issued.
  2. The contractor is responsible for checking all levels and dimensions on site and shall refer all discrepancies to the Engineer.
  3. Only drawings issued for CONSTRUCTION shall be used for construction purposes.
  4. Work to figured dimensions only. Do not scale print.
  5. Check size of drawing sheet against dimension marks at bottom left hand corner of sheet.

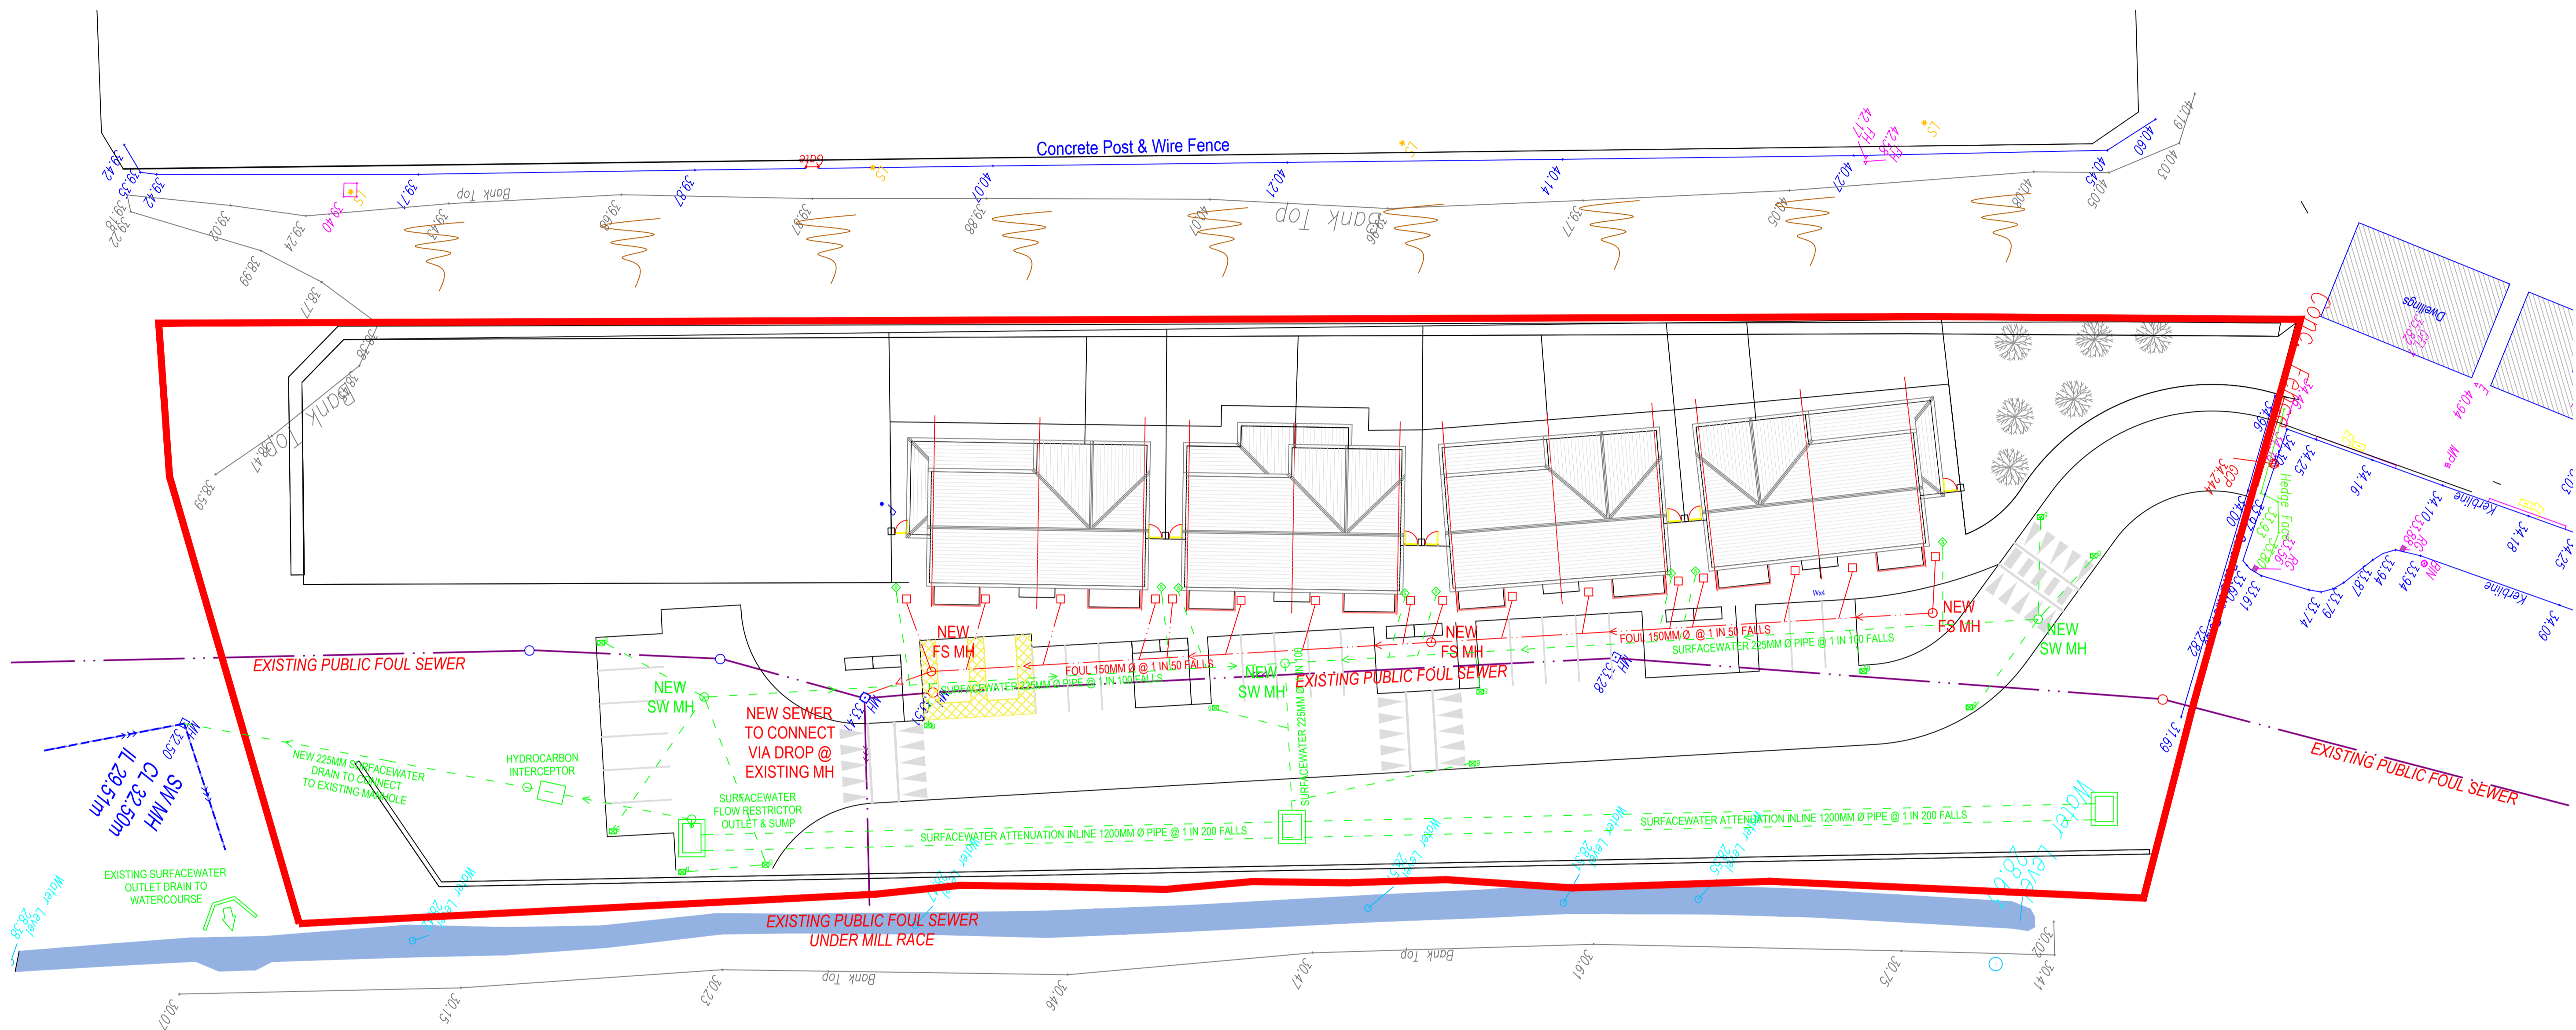

**DRAINAGE LAYOUT**  
SCALE 1:250

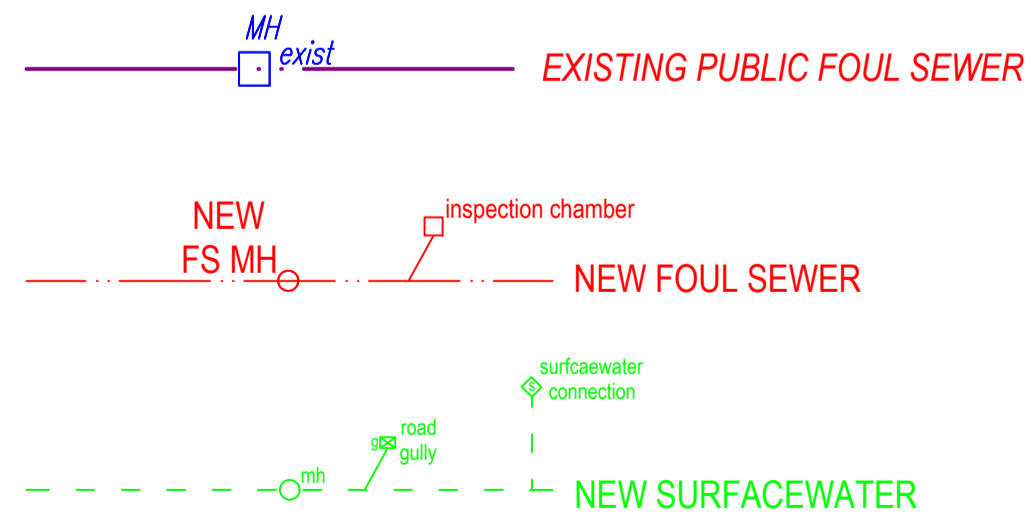

SHEET SIZE : A1  
0mm 50mm 100mm

Rev :	Note :	Drawn :	Approved :
Rev :	Note :	Drawn :	Approved :
P2	Date : 30 Oct. '19	Drawn : CF	Approved : CB

**DAVID KELLY PARTNERSHIP**  
CHARTERED ENGINEERS

Nelson House, Emmet Place, 10 Ormonde Street,  
Youghal, Co. Cork, Kilkenny.  
t. +353 (0)24 92412 t. +353 (0)56 7801260  
e. info@dkp.ie www.dkp.ie

Project : PROPOSED HOUSING DEVELOPMENT,  
AT GRAIGLISHONEEN, KILMACHTHOMAS,  
WATERFORD CITY AND COUNTY COUNCIL.  
ARCHITECT: C.J.FALCONER AND ASSOCIATES

Title : **FOUL & STORM DRAINAGE LAYOUT**

Purpose of Issue :	Scale :	
PART 8	1 : 250	
Project No. :	Drawing No. :	Issue No. :
19087	103	P2